

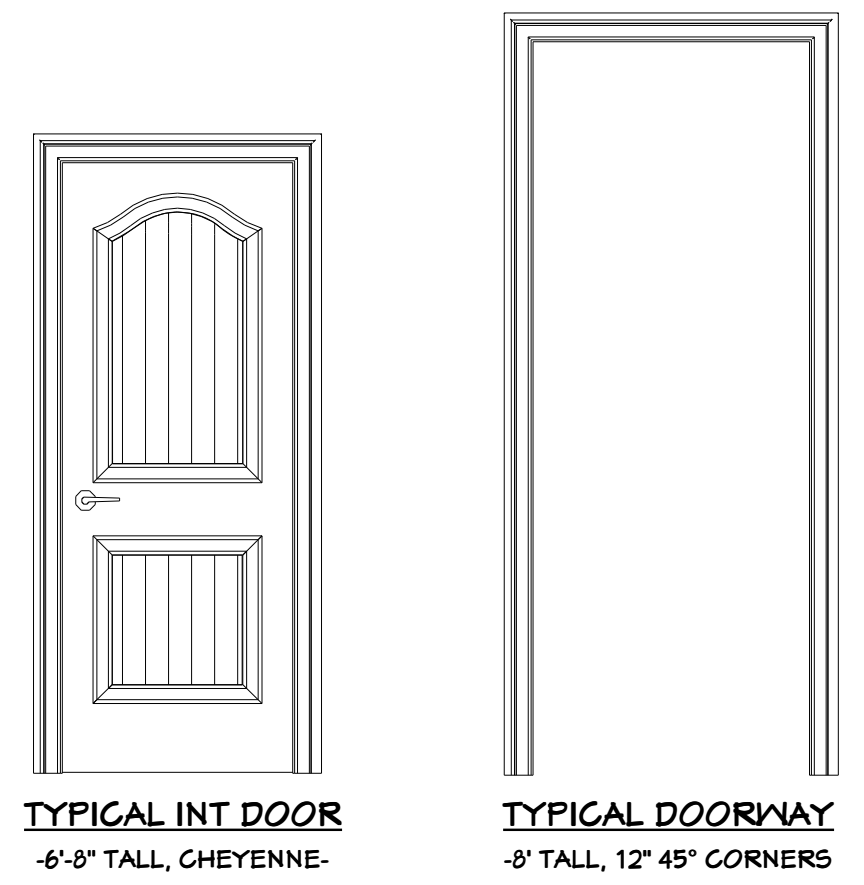


DOOR SCHEDULE						
NUMBER	VIEW	QTY	SIZE	DIMENSIONS	THK.	JAMB SIZE
D01		1	3068 L IN	36"X80"X1 3/8" L IN	1 3/8"	3/4"X4 1/2"
D02		4	2668 R IN	30"X80"X1 3/8" R IN	1 3/8"	3/4"X4 1/2"
D04		5	2668 L IN	30"X80"X1 3/8" L IN	1 3/8"	3/4"X4 1/2"
D05		1	2868 L IN	32"X80"X1 3/8" L IN	1 3/8"	3/4"X4 1/2"
D06		2	2068 R IN	24"X80"X1 3/8" R IN	1 3/8"	3/4"X4 1/2"
D07		1	3068 R EX	36"X80"X1 3/4" R EX	1 3/4"	3/4"X11 5/8"
D08		1	1868 R IN	20 1/4"X80"X1 3/8" R IN	1 3/8"	3/4"X4 1/2"
D09		2	2068 L IN	24"X80"X1 3/8" L IN	1 3/8"	3/4"X4 1/2"
D10		1	2068 L IN	24"X80"X3/8" L IN	3/8"	0"X3/8"
D12		1	3068 R EX	36"X80"X1 3/4" R EX	1 3/4"	3/4"X11 1/2"
D13		1	3068 L EX	36"X80"X1 3/4" L EX	1 3/4"	3/4"X11 1/2"

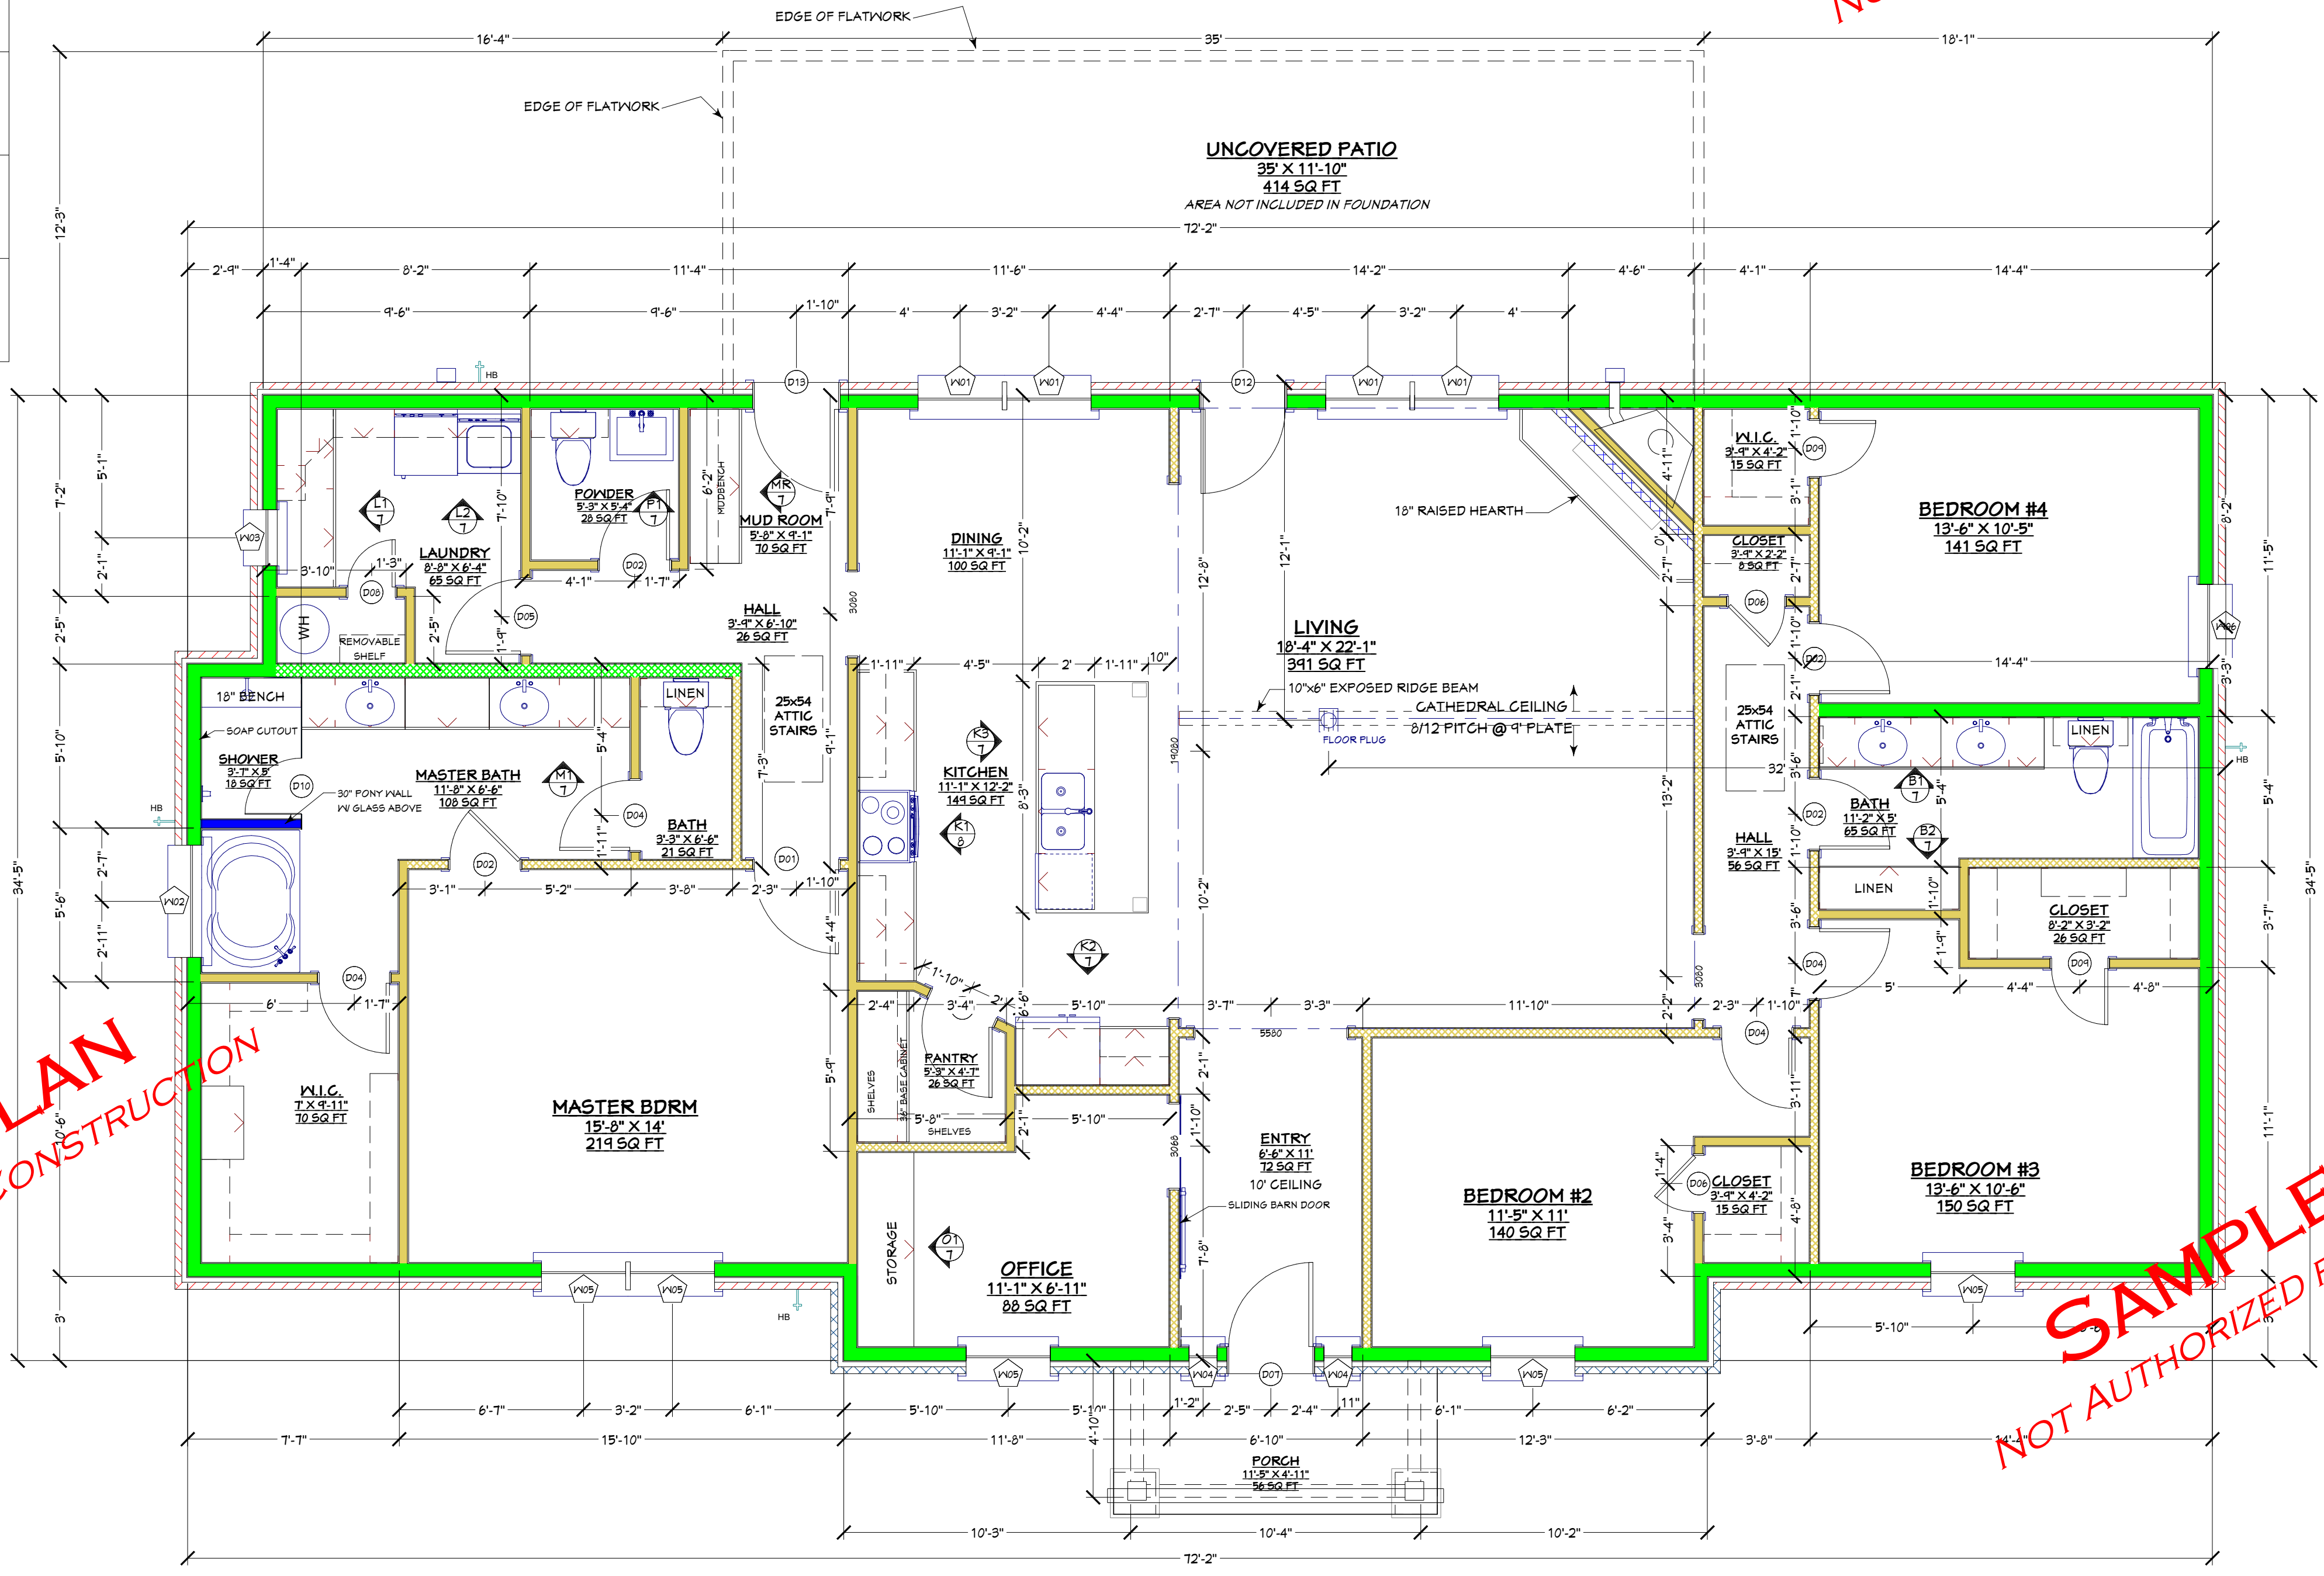

WINDOW SCHEDULE							
NUMBER	3D PERSPECTIVE	QTY	SIZE	DIMENSIONS	TOP	TEMP	LITES
W01		4	3060SH	36"X12"SH	80"	YES	1 / 1
W02		1	4040FX	48"X48"FX	80"	YES	1
W03		1	2030SH	24"X36"SH	80"	YES	1 / 1
W04		2	1060FX	12"X12"FX	80"		1X4
W05		5	3050SH	36"X60"SH	80"		2X6 2X2
W06		1	3050SH	36"X60"SH	80"		1 / 1

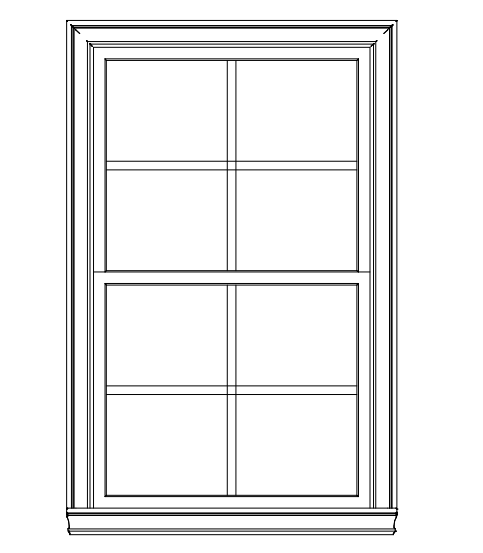

**MAIN FLOOR PLAN**

SCALE: 1/4" = 1'

BUILDING CONTRACTOR/HOME OWNER TO REVIEW & VERIFY ALL DIMENSIONS, SPECS, & CONNECTIONS BEFORE CONSTRUCTION BEGINS.

ELECTRICAL SYSTEM CODE: SEC.2701  
MECHANICAL SYSTEM CODE: SEC.2801  
PLUMBING SYSTEM CODE: SEC.2901

**NOTICE & DISCLAIMER**

UNDER NO CIRCUMSTANCES WILL TRACY'S CUSTOM HOMES BE LIABLE FOR ANY DAMAGES, WHETHER ARISING FROM TORT OR CONTRACT, INCLUDING LOSS OF DATA, LOST PROFITS, COST OF COVER, OR OTHER SPECIAL, INCIDENTAL, CONSEQUENTIAL OR INDIRECT DAMAGES ARISING OUT OF THE USE OF THESE DRAWINGS.

**SAMPLE PLAN**  
YOUR RESIDENCE  
**MAIN FLOOR PLAN**

2918 ANDREW DR  
FARMERSVILLE, TX 75442  
(903) 274-6022 CELL  
sales@tracycustomhomes.com  
www.tracycustomhomes.com

