


ELECTRICAL SCHEDULE			
2D	QTY	DESCRIPTION	ATTACHED TO
○	5	SCONCE (TRIPLE)	WALL
R	36	CAN LIGHT 6"	CEILING
○	2	PORCH LANTERN	WALL
TV	6	TELEVISION JACK	WALL
C6	4	CAT6	WALL
—	1	48" FLOURESCENT (48W4D)	CEILING
○	3	EXHAUST	CEILING
○	5	FLUSH DOME	CEILING
○	6	CEILING FAN	CEILING
○	2	EXHAUST (LIGHT)	CEILING
GFCI	8	GFCI	WALL
⌚	37	SINGLE POLE	WALL
SD	4	SMOKE DETECTOR (CEILING)	CEILING
○	1	BOWL PENDANT CHANDELIER	CEILING
○	1	CONTEMPORARY CHANDELIER	CEILING
⌚	3	FOUR WAY	WALL
⌚	4	220V	WALL
○	1	HALF CONE	WALL
○	3	BLOWN GLASS PENDANT	CEILING
⌚	4	THREE WAY	WALL
○	1	FLOOR PLUG	FLOOR
○	2	CABINET DUPLEX	FLOOR
DW	1	DISHWASHER	WALL
GD	2	GARBAGE DISPOSAL	WALL
—	3	UNDER CABINET LIGHT	
WP	4	DUPLEX (WEATHERPROOF)	WALL
R	1	EYEBALL	CEILING
○	3	CAGED LANTERN SCONCE	WALL
⌚	1	TIMER	WALL
○	1	DOORBELL	WALL
DC	1	DOOR CHIME	WALL
○	1	ELECTRICAL METER SOCKET	WALL
EP	1	ELECTRICAL PANEL	WALL
SD	2	SMOKE DETECTOR (WALL)	WALL
○	36	DUPLEX	WALL
○	7		WALL

SAMPLE PLAN  
NOT AUTHORIZED FOR CONSTRUCTION

SAMPLE PLAN  
NOT AUTHORIZED FOR CONSTRUCTION

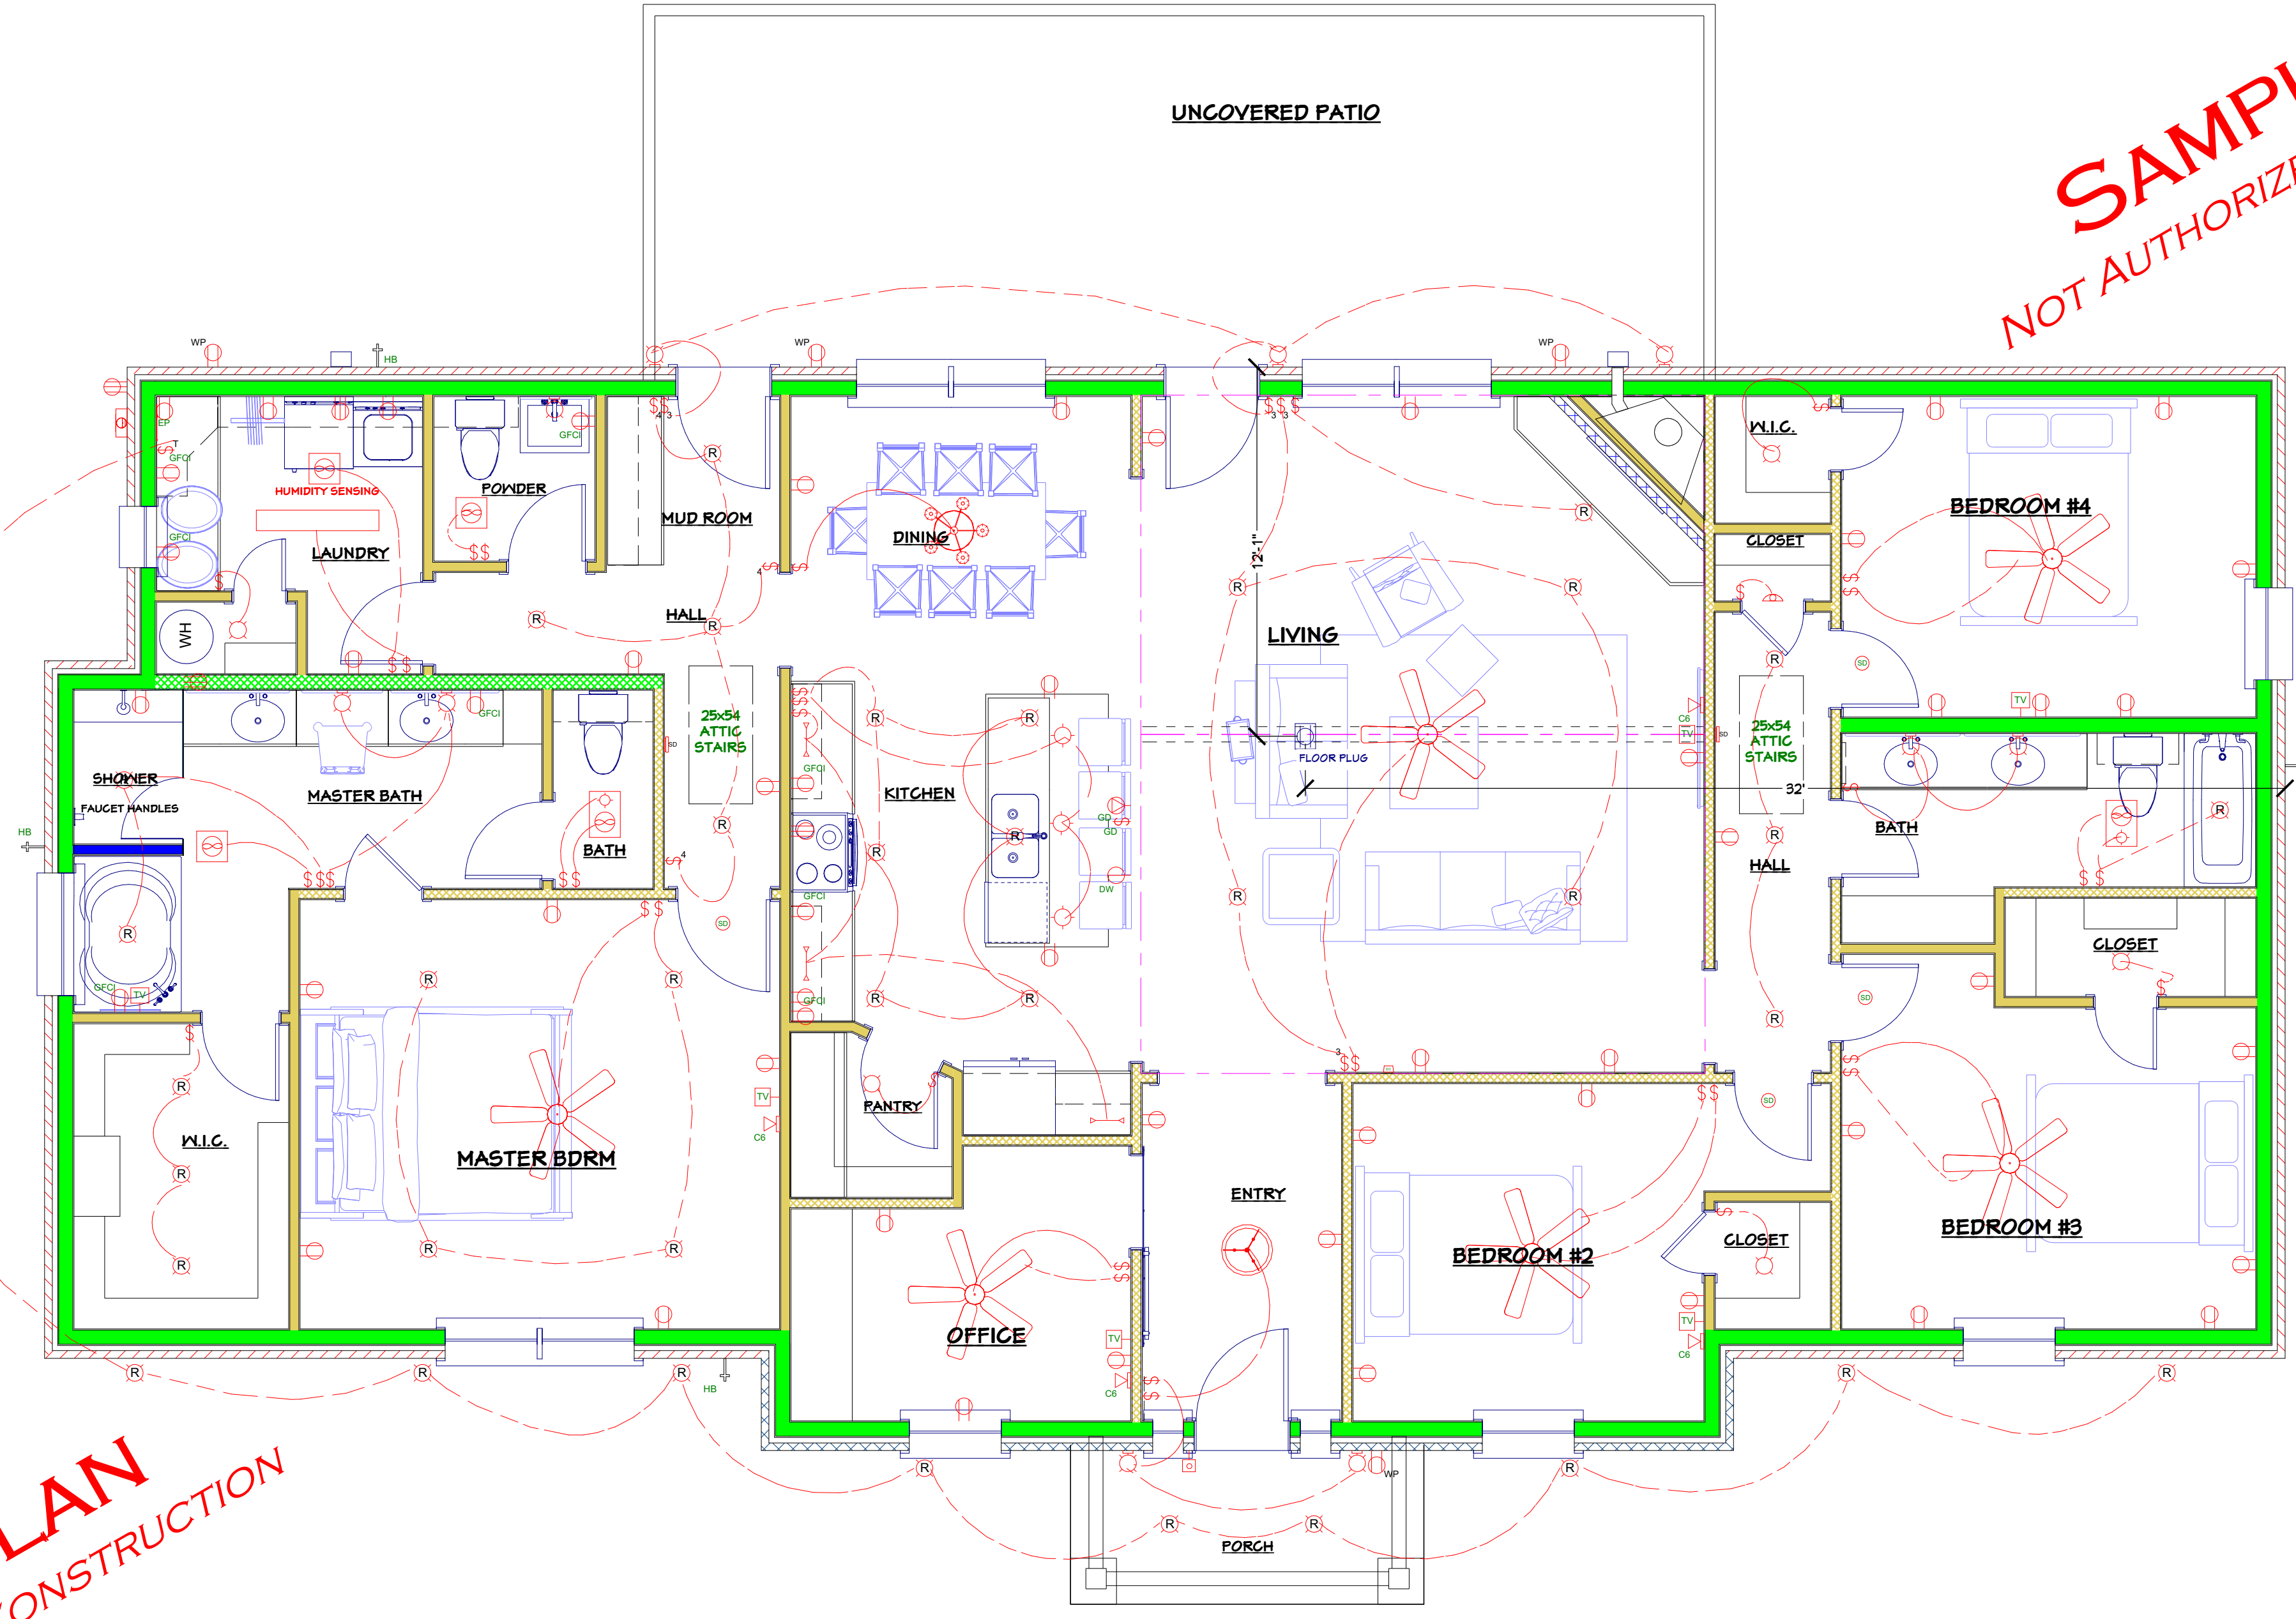

**ELECTRICAL PLAN**  
SCALE: 1/4" = 1'

SAMPLE PLAN  
NOT AUTHORIZED FOR CONSTRUCTION

SAMPLE PLAN  
NOT AUTHORIZED FOR CONSTRUCTION

- Note to Contractor:**
- I. Walk-thru to be held with Owner before Installation
  - II. All Kitchen and Bathroom Outlets to be GFI
  - III. Single Door Closet Light Switches should be Door Contact Switches
  - IV. Security System to be discussed with Owner
  - V. Audio/Video to be discussed with Owner
  - VI. Place outlets in the roof eaves for Christmas Lights. Tie these to a Mechanical Timer with front eave lights and front porch lights.
  - VII. Place Dimmer Switches on Can Lights in Living, Kitchen, Master Bedroom
  - VIII. Use LED CAN light fixtures and LED Bulbs where applicable

**NOTICE & DISCLAIMER**  
UNDER NO CIRCUMSTANCES WILL TRACY'S CUSTOM HOMES BE LIABLE FOR ANY DAMAGES, WHETHER ARISING FROM TORT OR CONTRACT, INCLUDING LOSS OF DATA, LOST PROFITS, COST OF COVER, OR OTHER SPECIAL, INCIDENTAL, CONSEQUENTIAL OR INDIRECT DAMAGES ARISING OUT OF THE USE OF THESE DRAWINGS.

SAMPLE PLAN  
YOUR RESIDENCE  
ELECTRICAL

2918 ANDREW DR  
FARMERSVILLE, TX 75442  
(903) 274-6022 CELL  
sales@tracyscustomhomes.com  
www.tracyscustomhomes.com

